

- CIPP LINING NOTES:


-
- EXISTING 36" DIP RWRP EFFLUENT PIPELINE
- SEE DWG C-1 FOR MODIFICATIONS TO WASSON SILL DIVERSION STRUCTURE (DP-002) AND WASSON SILL VAULT (DP-002)
- EXISTING 36" RCP AG PIPELINE WITH STATIONING PER PROJECT 3-03040, SEE DWG C-3 THRU C-8
- EXISTING 36" RCP SIPHON
- INSTALL EXTENSION TO EXISTING AG PIPELINE AND DIVERSION DISSIPATION DISCHARGE STRUCTURE (DP-00A) PER DWG C-2

DRAWING
G-4

OF 15 SHEETS

FILE
9846 SH04
G-4

ENG W.O. #75926

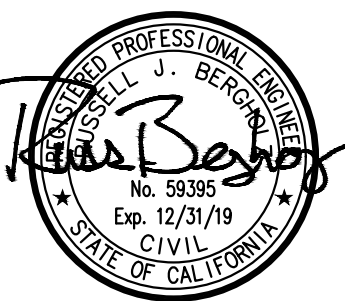

DUDEK
605 Third Street Encinitas, CA 92024
760.942.5147 Fax 760.632.0164

WATER/SEWER APPROVED BY:
ELSINORE VALLEY MUNICIPAL WATER DISTRICT

ASSISTANT GENERAL MANAGER DATE

DEPARTMENT APPROVALS	

ENGINEERING MANAGER	WATER OPERATIONS MANAGER	WASTEWATER OPERATIONS MANAGER
---------------------	--------------------------	-------------------------------

[illegible]

APPROVED BY: *Russ Bergholz*
 RUSS BERGHOLZ
 REGISTERED CIVIL ENGINEER No. 59395
 DATE: *2/20/10* REGISTRATION EXPIRES *12/31/2019*
 APPROVED BY:

 RIVERSIDE COUNTY, CALIFORNIA
 DATE: _____ FOR ROAD COMMISSIONER


REGIONAL AGRICULTURAL PIPELINE CONVERSION

SCALE AS NOTED	BENCH MARK
DATE 8/30/2018	


ELSINORE VALLEY MUNICIPAL WATER DISTRICT

SITE PLAN

W.O.p.c.:	W.O.i.:	P.Z.:	FOR:
-----------	---------	-------	------

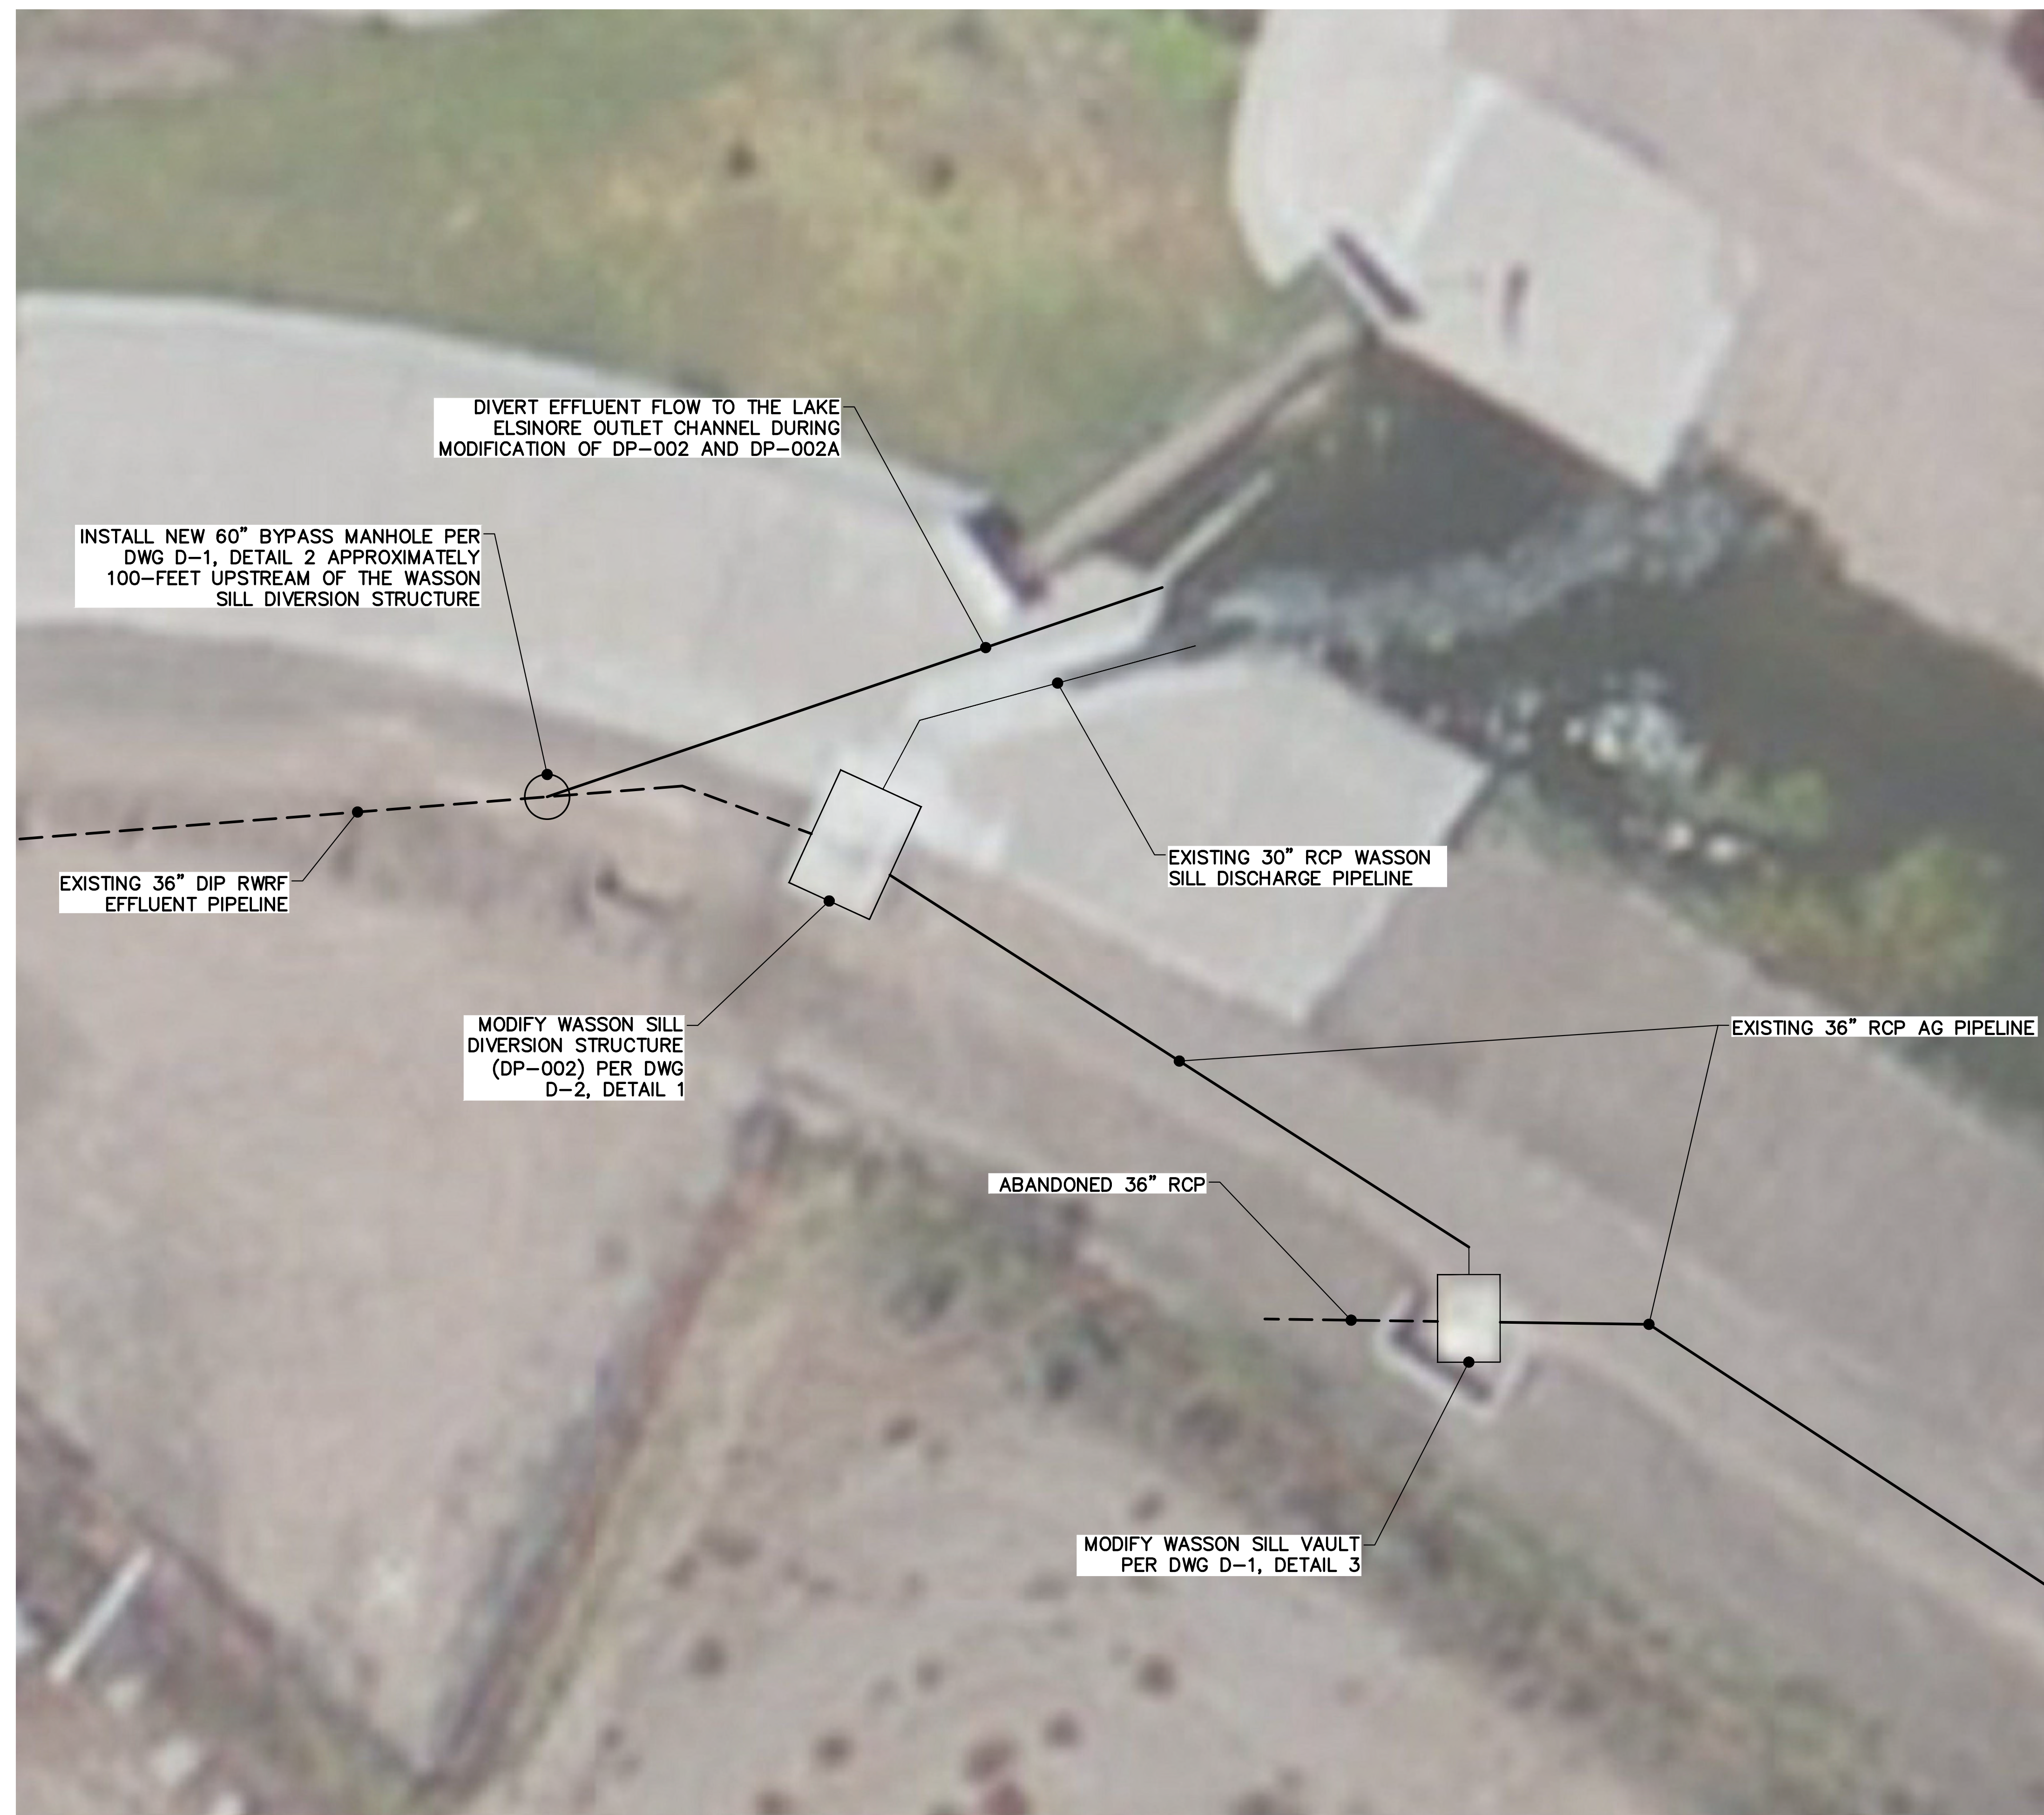

- NOTES:**
1. CONTRACTOR SHALL FIELD LOCATE AND VERIFY ALL EXISTING STRUCTURES PRIOR BEGINNING CONSTRUCTION.
 2. CONTRACTOR SHALL LOCATE NEW MANHOLE UPSTREAM OF DP-002 TO BE UTILIZED FOR BY-PASSING PURPOSES AND SHALL REMAIN IN PLACE ONCE ALL WORK IS COMPLETE. INSTALL SMART COVER SYSTEM FOR THE MANHOLE. CONTRACTOR SHALL PROVIDE A FOUR (4) WEEK WRITTEN NOTICE TO THE DISTRICT FOR ANY SHUTDOWN ACTIVITIES. THE MAXIMUM SHUTDOWN TIME SHALL BE 2-HOURS.

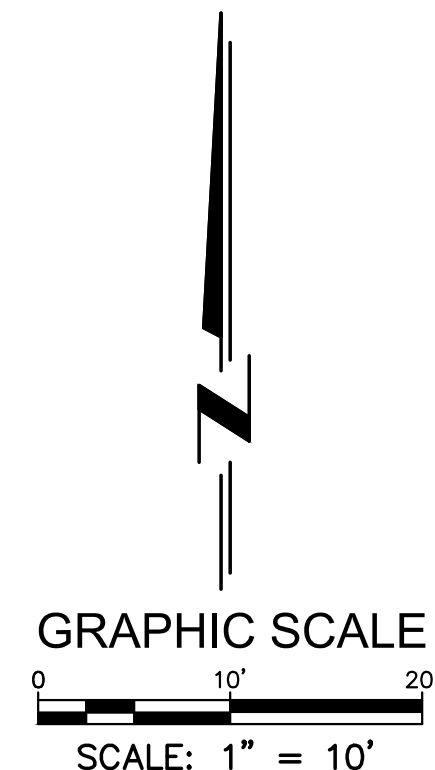

LINE IS 2 INCHES
AT FULL SIZE
(IF NOT 2"—SCALE ACCORDINGLY)

 DUDEK 605 Third Street Encinitas, CA 92024 760.942.5147 Fax 760.632.0164	WATER/SEWER APPROVED BY: ELSINORE VALLEY MUNICIPAL WATER DISTRICT			MARK		REVISIONS		APPR. DATE		APPROVED BY: RUSS BERGHOLZ <i>Russ Bergholz</i> REGISTERED CIVIL ENGINEER No. 59395 DATE: 8/30/18 REGISTRATION EXPIRES 12/31/2019		REGIONAL AGRICULTURAL PIPELINE CONVERSION		ELSINORE VALLEY MUNICIPAL WATER DISTRICT				5 OF 15 SHEETS FILE 9846 SH05 C-1		
	ASSISTANT GENERAL MANAGER _____ DATE _____									APPROVED BY: _____		SCALE AS NOTED		BENCH MARK		WASSON SILL DIVERSION STRUCTURE MODIFICATIONS (DP-002)				
	DEPARTMENT APPROVALS									DATE: _____		DATE 8/30/2018				W.O.p.c.: _____ W.O.j.: _____ P.Z.: _____ FOR: _____				
	ENGINEERING MANAGER _____ WATER OPERATIONS MANAGER _____ WASTEWATER OPERATIONS MANAGER _____									DESIGNED BY: _____ DRAWN BY: KJK CHECKED BY: _____		DATE: _____				24X36				